



**Mark Bromley AIA**  
**Architect**  
 2.461.5471  
 mark@hillviewdesign.com

**n Bush**  
2.310.4570  
n@hillviewdesign.com

**John Linn AIA**  
**Architect**  
 2.734.0934  
 jlinn@hillviewdesign.com

These documents are the work instruments of Hillview Design Collaborative and have been prepared specifically and solely for the project named herein. They are suitable for use on the subjects or in other situations without the participation of Hillview Design Collaborative. The production of these documents for use other than named project is prohibited. Hillview Design Collaborative shall be deemed author and owner of these documents and all retain common law, statutory and other reserved rights, including copyright.

## CONTACTS

## PROJECT

## Ellendorf Wedding Barn

**nderhill,  
ermont**

#### ISSUE/ REVISION LOG

5.30.15
7.06.15

[illegible]


HEET TITLE

## Stable Floor Plan

SCALE: AS NOTED

SHEET NUMBER

**A1.00**

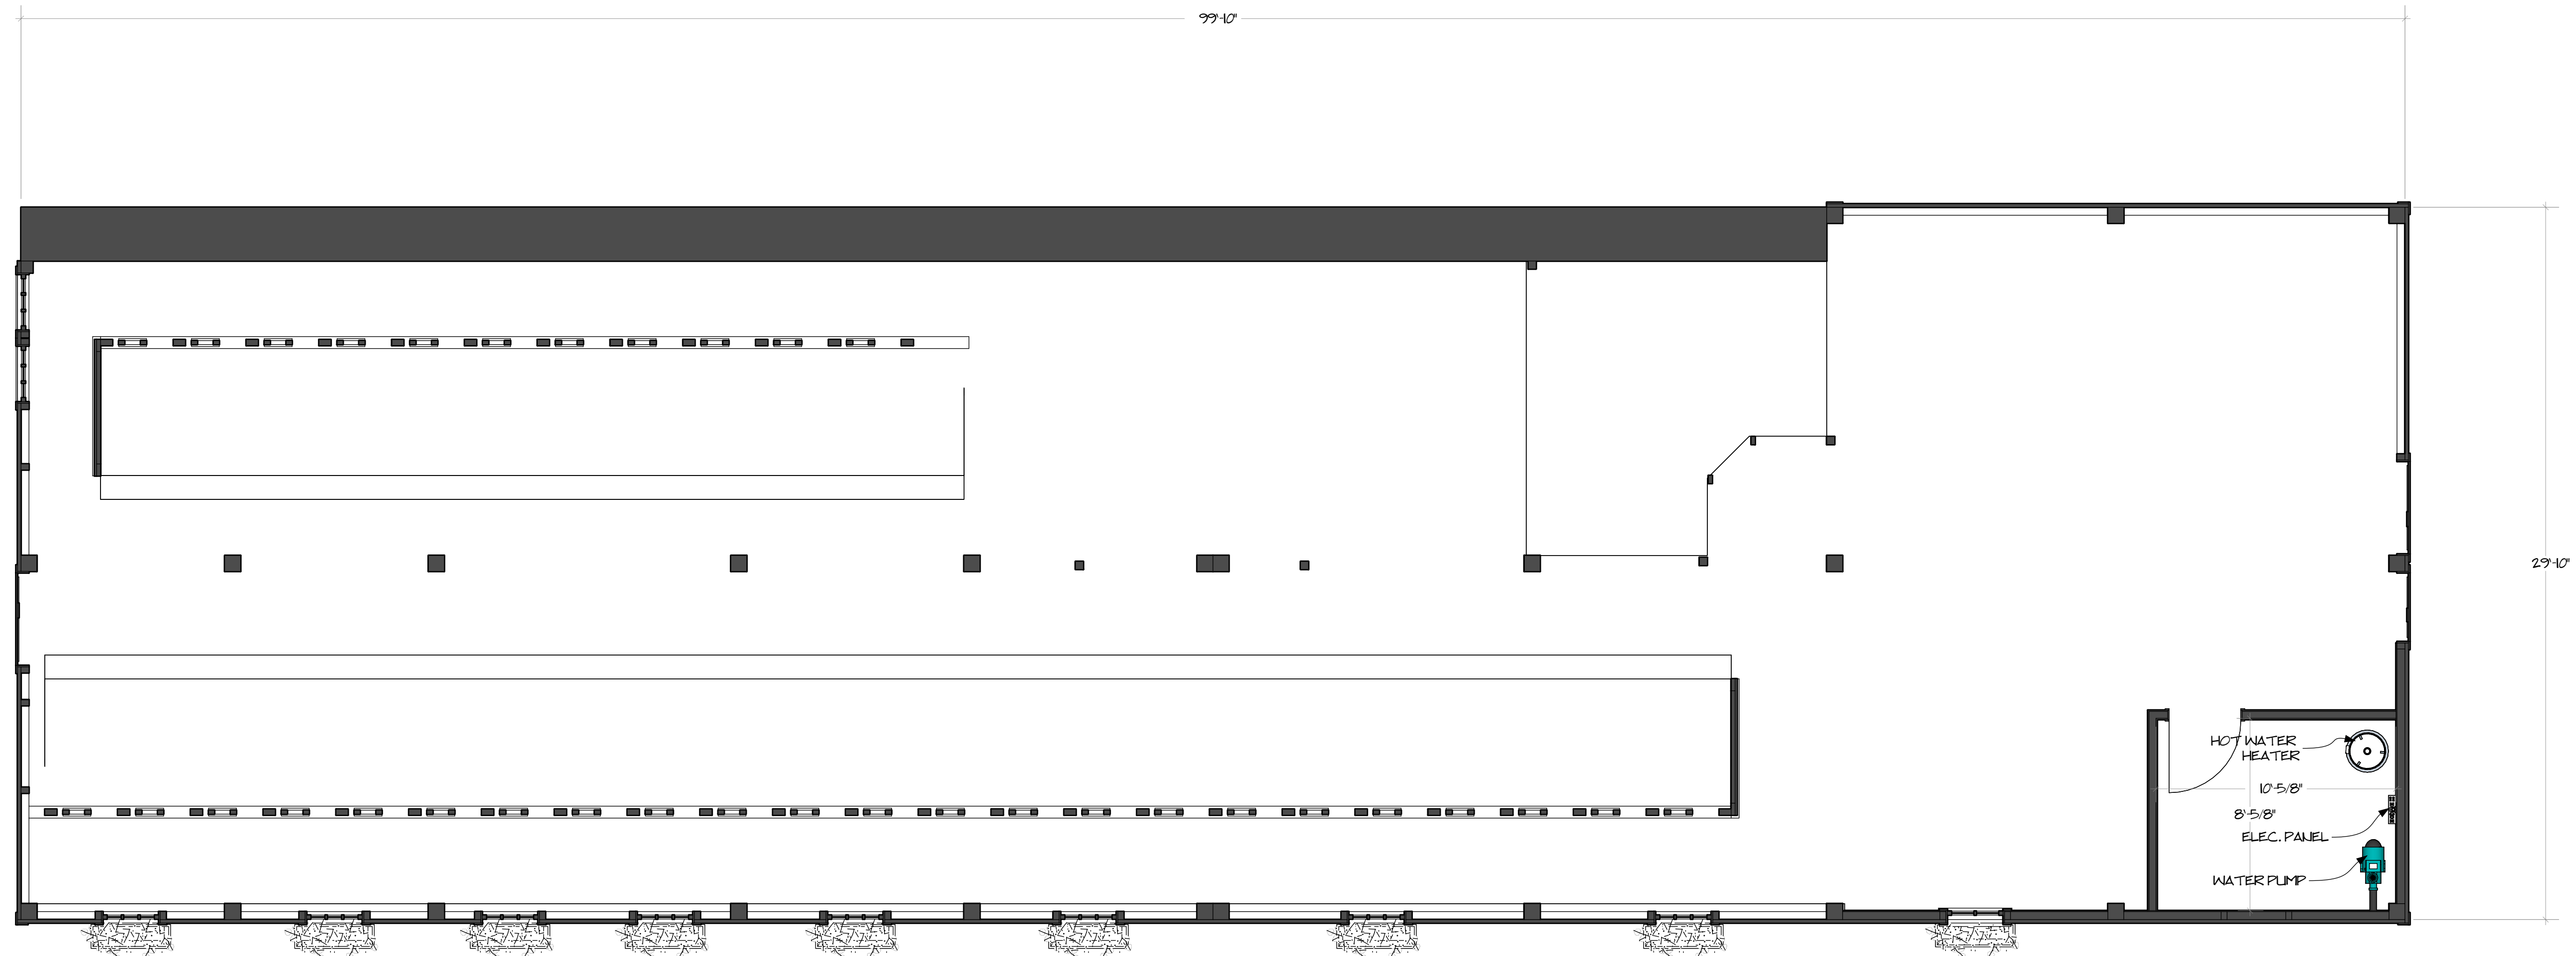

1 STABLE FLOOR PLAN  
SCALE 1/4" = 1'-0" +





**Mark Bromley AIA**  
**Architect**  
 2.461.5471  
[mark@hillviewdesign.com](mailto:mark@hillviewdesign.com)

**n Bush**  
2.310.4570  
n@hillviewdesign.com

**John Linn AIA**  
**Architect**  
 2.734.0934  
 jlinn@hillviewdesign.com

These documents are the work instruments of Hillview Design Collaborative and have been prepared specifically and solely for the project named herein. They are not suitable for use on other projects or in other circumstances without the participation of Hillview Design Collaborative. The production of these documents for use other than the named project is prohibited. Hillview Design Collaborative shall be deemed author and owner of these documents and all retain common law, statutory and other reserved rights, including copyright.

## CONTACTS

## PROJECT

**Illendorf  
Wedding Barn**

**nderhill,  
ermont**

### ISSUE/ REVISION LOG

5.30.15
7.06.15

[illegible]


MEET TITLE

## Barn Floor Plan

SCALE: AS NOTED

SHEET NUMBER

## A1.10

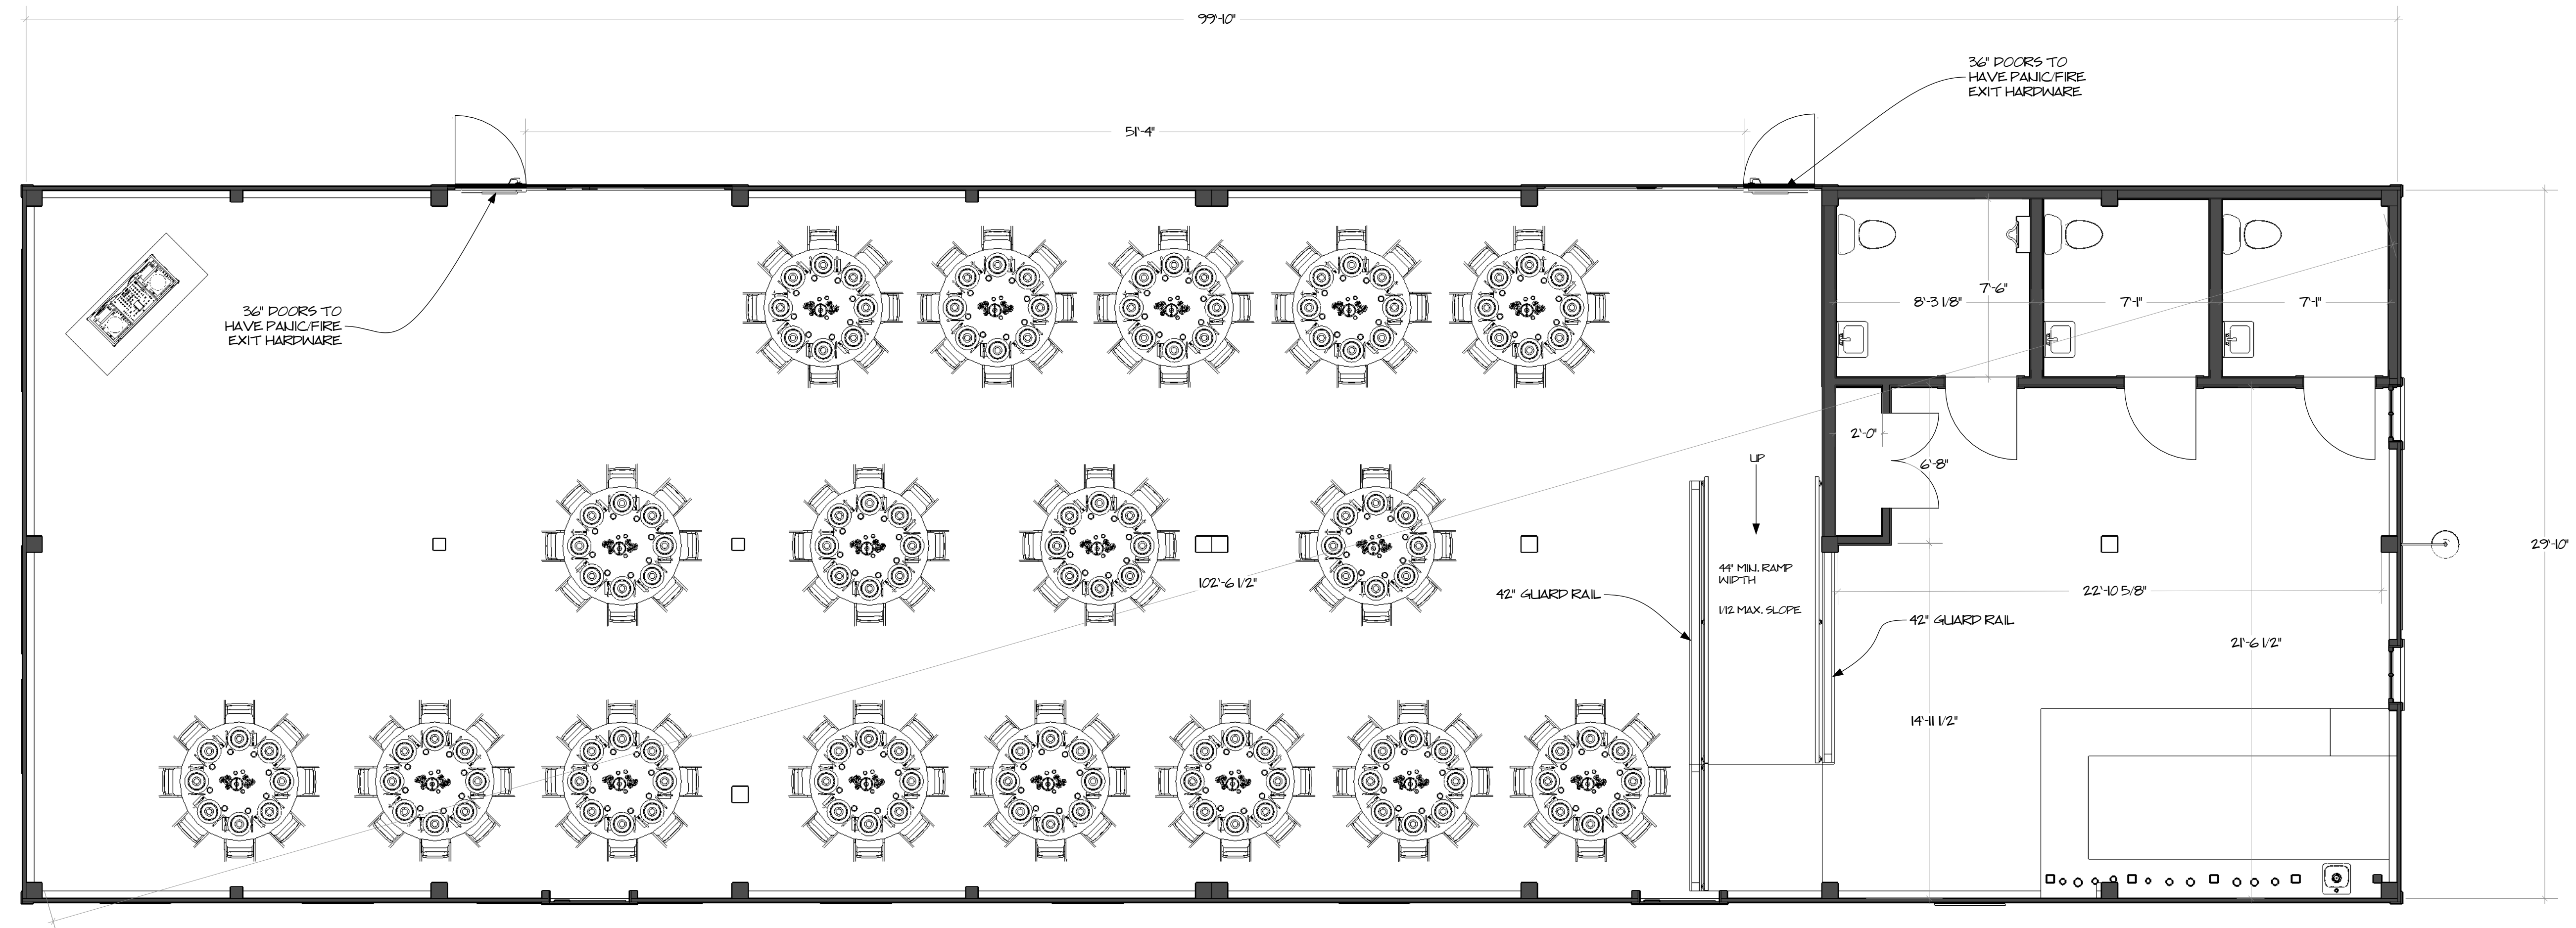

## 1 BARN FLOOR PLAN





**Mark Bromley AIA**  
**Architect**  
 2.461.5471  
 mark@hillviewdesign.com

**n Bush**  
2.310.4570  
n@hillviewdesign.com

**John Linn AIA**  
**Architect**  
 2.734.0934  
 jlnn@hillviewdesign.com

These documents are the work instruments of Hillview Design Collaborative and have been prepared specifically and solely for the project mentioned herein. They are not suitable for use on other projects or in other situations without the participation of Hillview Design Collaborative. The production of these documents for use other than named project is prohibited. Hillview Design Collaborative shall be deemed author and owner of these documents and shall retain common law, statutory and other reserved rights, including copyright.

## CONTACTS

## PROJECT

## Ellendorf Wedding Barn

**nderhill,  
ermont**

ISSUE/ REVISION LOG

5.30.15

7.06.15

---

--	--

---

---

--

---

\_\_\_\_\_

\_\_\_\_\_

11/11/2016

--	--

---

---




HEET TITLE

## Bathroom Plan

SCALE: AS NOTED

SHEET NUMBER

## A1.11

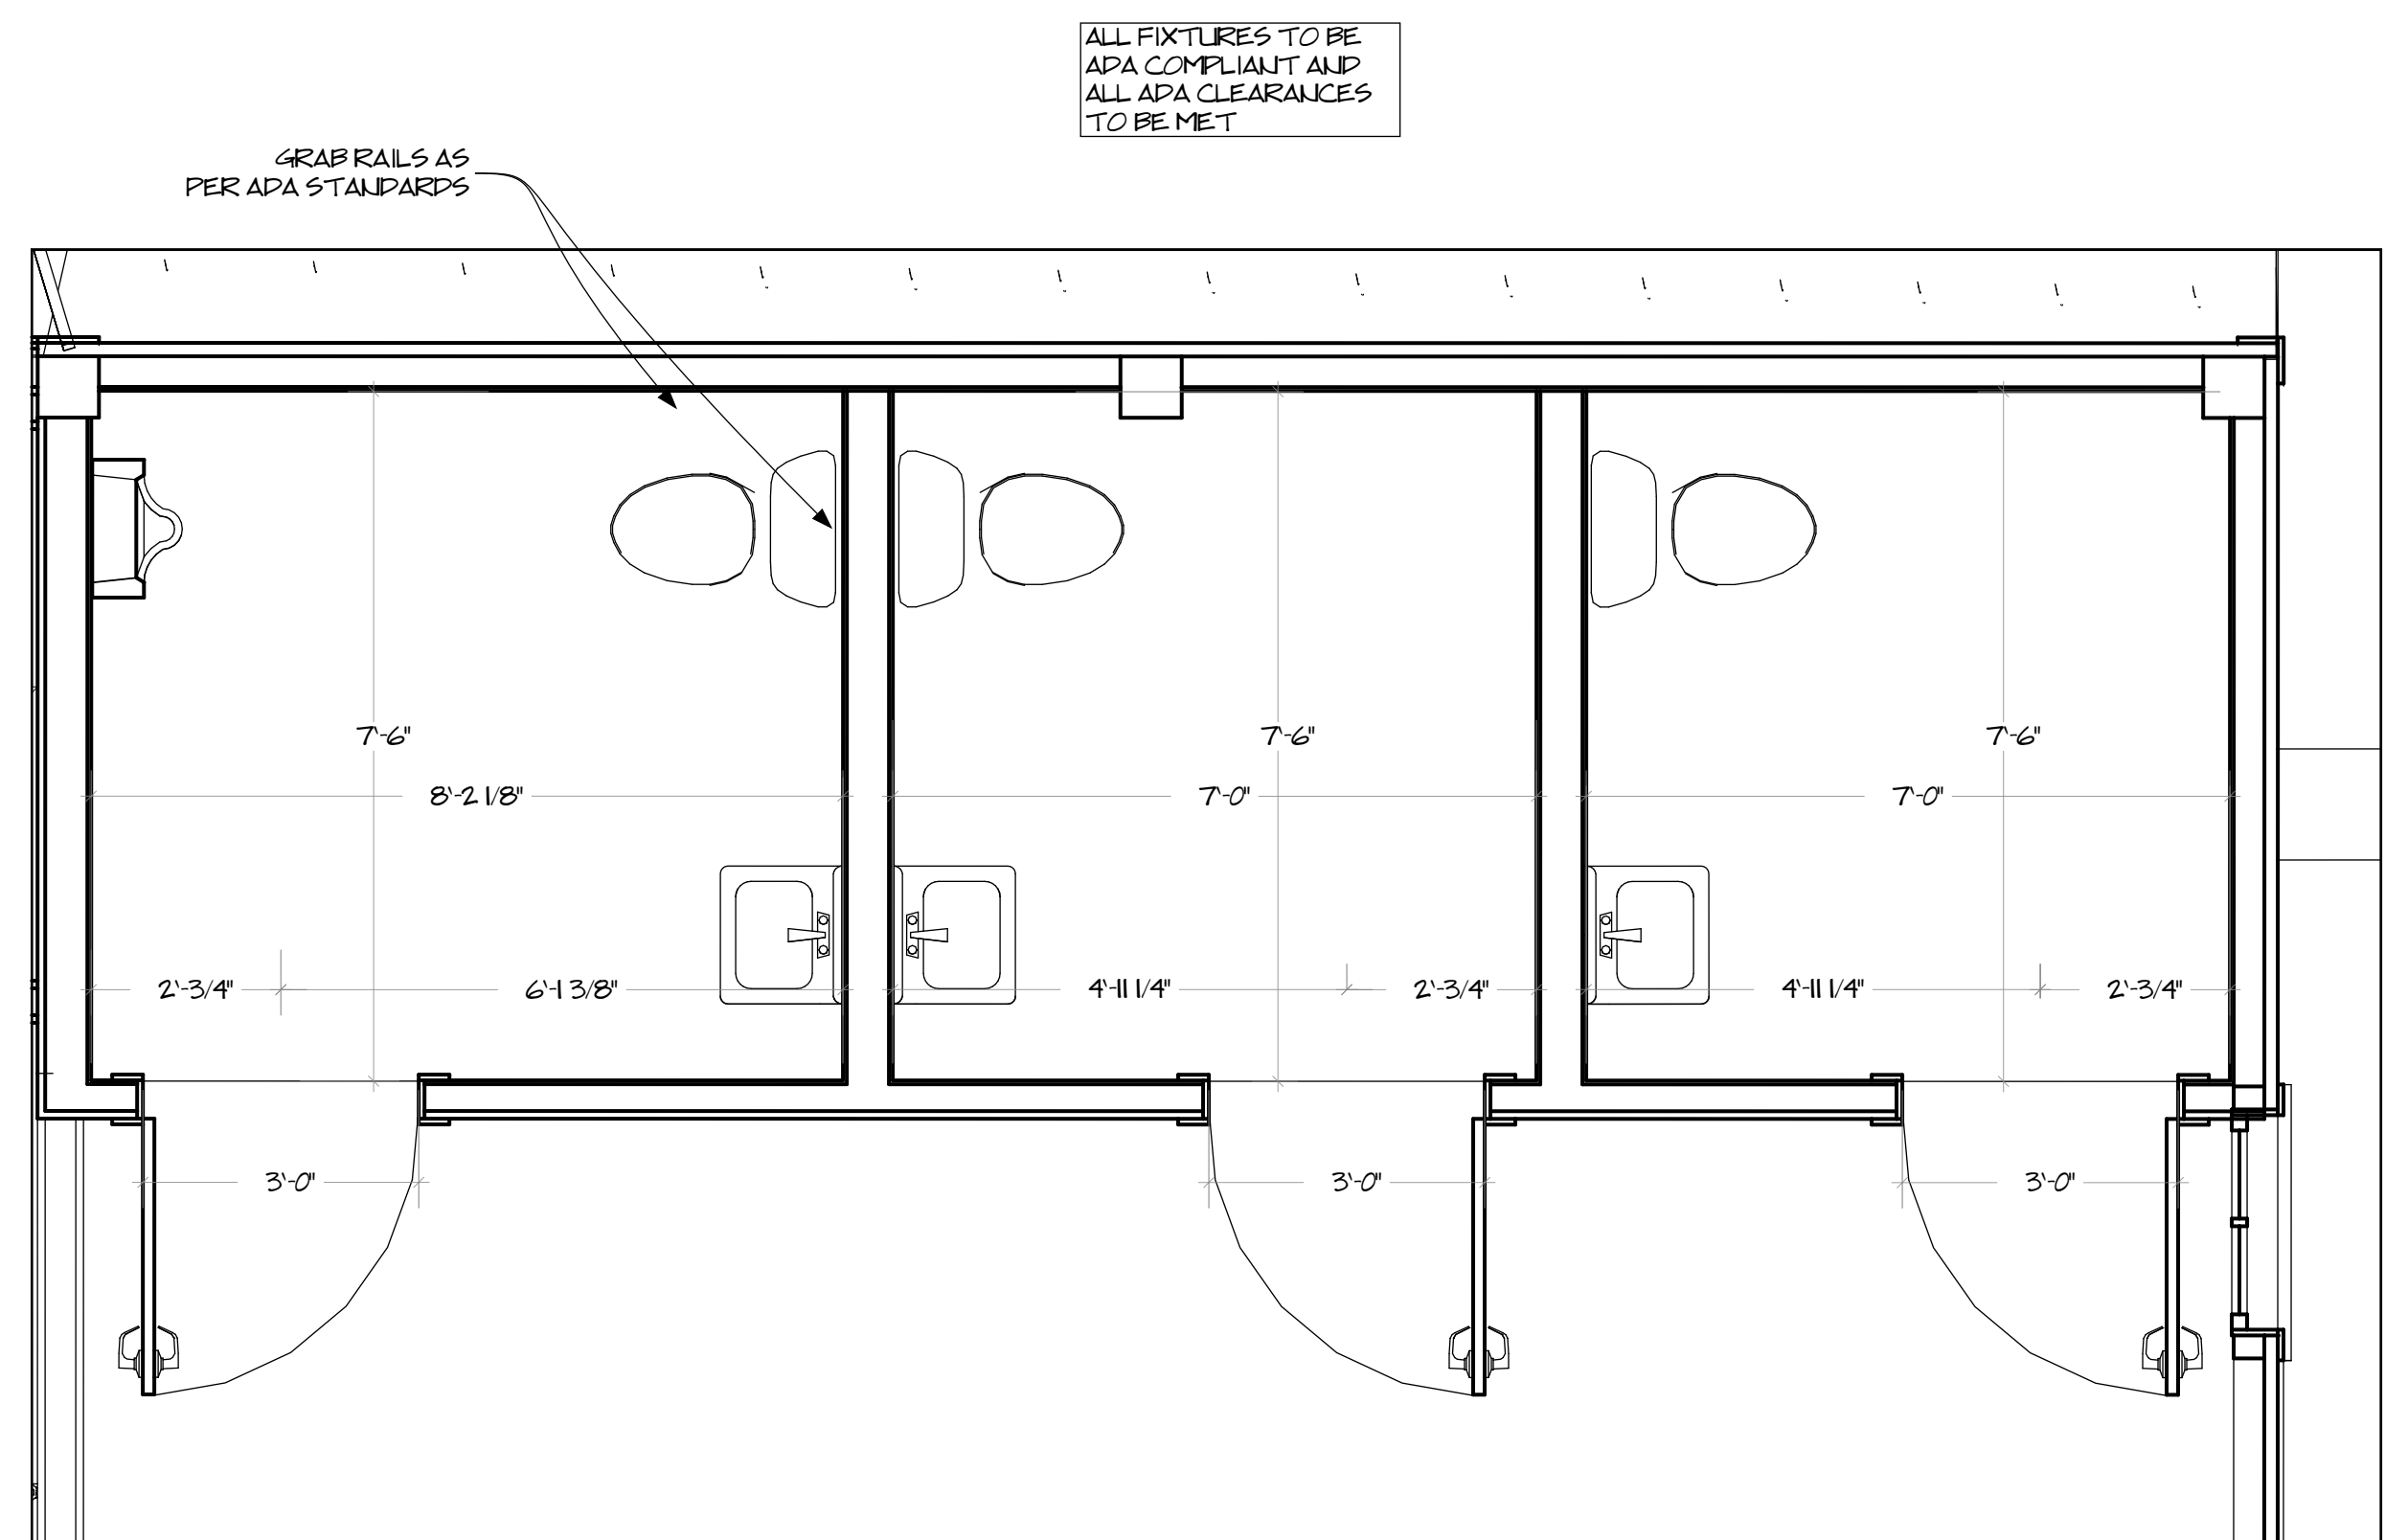

**BATHROOM PLAN**  
SCALE 1/2" = 1'-0" \*





**Mark Bromley AIA**  
**Architect**  
 2.461.5471  
 mark@hillviewdesign.com

**n Bush**  
2.310.4570  
n@hillviewdesign.com

**John Linn AIA**  
**Architect**  
 2.734.0934  
 jlnn@hillviewdesign.com

These documents are the work instruments of Hillview Design Collaborative and have been prepared specifically and solely for the project mentioned herein. They are not suitable for use on other projects or in other situations without the participation of Hillview Design Collaborative. The production of these documents for use other than named project is prohibited. Hillview Design Collaborative shall be deemed author and owner of these documents and shall retain common law, statutory and other reserved rights, including copyright.

## CONTACTS

## PROJECT

## Allendorf Wedding Barn

**nderhill,  
ermont**

### ISSUE/ REVISION LOG

5.30.15
7.06.15

[illegible]


EET TITLE

## Elevations

SCALE: AS NOTED

SHEET NUMBER

## A2.01

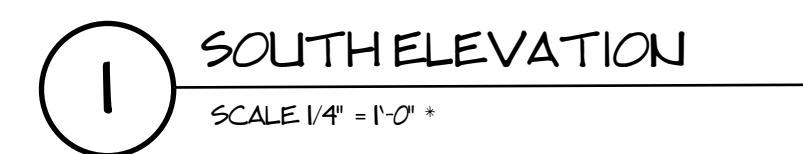



**Mark Bromley AIA**  
**Architect**  
 2.461.5471  
 mark@hillviewdesign.com

**n Bush**  
2.310.4570  
n@hillviewdesign.com

**John Linn AIA**  
**Architect**  
 2.734.0934  
 jlinn@hillviewdesign.com

These documents are the work instruments of Hillview Design Collaborative and have been prepared specifically and solely for the project named herein. They are suitable for use on the subjects or in other situations without the participation of Hillview Design Collaborative. The production of these documents for use other than named project is prohibited. Hillview Design Collaborative shall be deemed author and owner of these documents and all retain common law, statutory and other reserved rights, including copyright.

## CONTACTS

## PROJECT

## Ellendorf Wedding Barn

**nderhill,  
ermont**

ISSUE/ REVISION LOG

5.30.15
7.06.15

[illegible]


EET TITLE

## Elevations

SCALE: AS NOTED

SHEET NUMBER

## A2.02

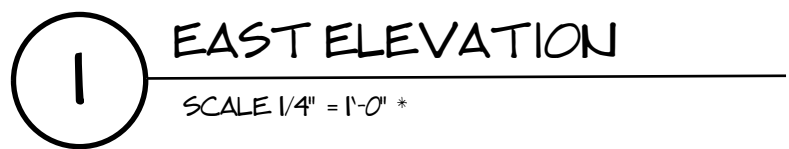





**Mark Bromley AIA**  
**Architect**  
 2.461.5471  
 mark@hillviewdesign.com

**n Bush**  
2.310.4570  
n@hillviewdesign.com

**John Linn AIA**  
**Architect**  
2.734.0934  
jlinn@hillviewdesign.com

These documents are the risk instruments of Hillview Design Collaborative and have been prepared specifically and solely for the project named herein. They are not available for use on other projects or in other situations without the participation of Hillview Design Collaborative. Production of these documents for use other than the named project is prohibited. Hillview Design Collaborative shall be deemed author and owner of these documents and shall retain common law, statutory and other reserved rights, including copyright.

## CONTACTS

## PROJECT

## Ellendorf Wedding Barn

**nderhill,  
ermont**

### ISSUE/ REVISION LOG

5.30.15
7.06.15

[illegible]


HEET TITLE

## Elevations

SCALE: AS NOTED

SHEET NUMBER

## A2.03

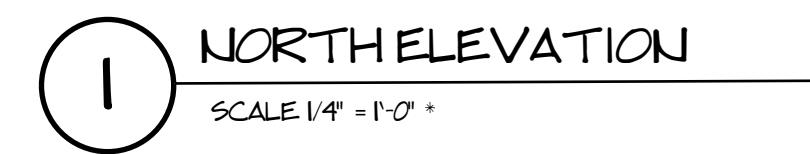





**Mark Bromley AIA**  
Architect  
802.461.5471  
mark@hillviewdesign.com

**Ben Bush**  
802.310.4570  
ben@hillviewdesign.com

**John Linn AIA**  
Architect  
802.734.0934  
john@hillviewdesign.com

These documents are the work instruments of Hillview Design Collaborative and have been prepared specifically and solely for the project named herein. They are not to be used for any other projects or in other locations without the participation of Hillview Design Collaborative. Reproduction of these documents for use other than the named project is prohibited. Hillview Design Collaborative shall be deemed author and owner of these documents and shall retain common law, statutory and other reserved rights, including copyright.

## CONTACTS

## PROJECT

## Allendorf Wedding Barn

## Underhill, Vermont

ISSUE/ REVISION LOG

	06.30.15
	07.06.15

[illegible]


SHEET TITLE

## Elevations

**SCALE: AS NOTED**

SHEET NUMBER

## A2.04

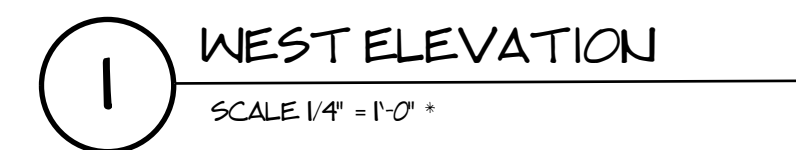



**n Bush**  
2.310.4570  
n@hillviewdesign.com

These documents are the work instruments of Hillview Design Collaborative and have been prepared specifically and solely for the project named herein. They are suitable for use on the subjects or in other situations without the participation of Hillview Design Collaborative. The production of these documents for use other than named project is prohibited. Hillview Design Collaborative shall be deemed author and owner of these documents and all retain common law, statutory and other reserved rights, including copyright.

## PROJECT

**nderhill,  
ermont**

### ISSUE/ REVISION LOG

5.30.15

7.06.15

---

---

---

---

---

---

---

---


EET TITLE

## Electrical Plans

**SCALE: AS NOTED**

## SHEET NUMBER

**€1.00**

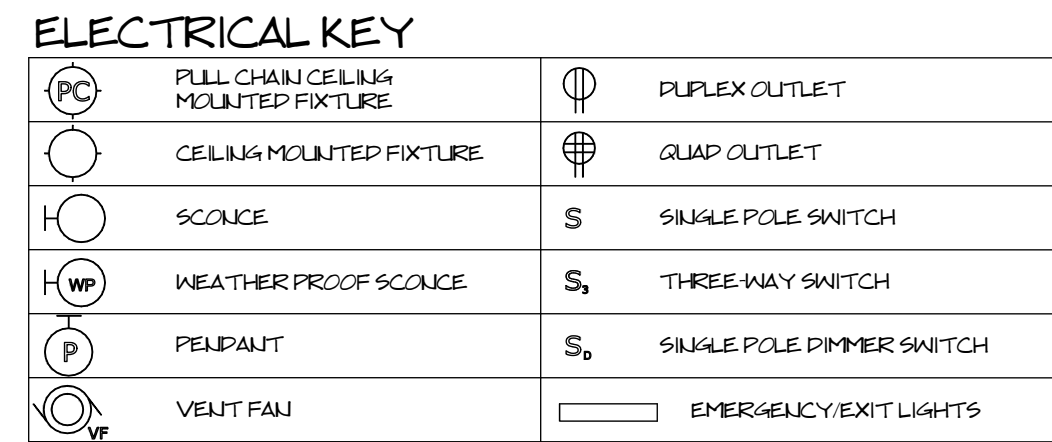

1 LOWER LEVEL ELECTRICAL PLAN  
SCALE 1/4" = 1'-0" +







**Mark Bromley AIA**  
**Architect**  
 2.461.5471  
[mark@hillviewdesign.com](mailto:mark@hillviewdesign.com)

**n Bush**  
2.310.4570  
n@hillviewdesign.com

**John Linn AIA**  
**Architect**  
 2.734.0934  
 jn@hillviewdesign.com

These documents are the risk instruments of Hillview Design Collaborative and have been prepared specifically and solely for the project named herein. They are not available for use on other projects or in other situations without the participation of Hillview Design Collaborative. The production of these documents for use other than the named project is prohibited. Hillview Design Collaborative shall be deemed author and owner of these documents and shall retain common law, statutory and other reserved rights, including copyright.

## CONTACTS

## PROJECT

**Illendorf  
Wedding Barn**

**nderhill,  
ermont**

### ISSUE/ REVISION LOG

5.30.15

7.06.15

---

--	--

---

---

---

--	--

--

---

\_\_\_\_\_

\_\_\_\_\_

11/11/2016

--	--

--	--


HEET TITLE

## Electrical Plans

SCALE: AS NOTED

SHEET NUMBER

## E1.10



## ELECTRICAL KEY

